



Revision		
REV	DATE	DESCRIPTION
A	11-7	Initial Release
C	2.21.18	Contract Submittal

William & Loree Beth Harris
4309 Franklin Rd
Lebanon
Tennessee
37090

PHONE:

Area Schedule

AREA SCHEDULE	
NAME	AREA
Main Floor	2556 sq ft.
Finished Second Floor	1478 sq ft.
Garage	707 sq ft.
Covered Porch	786 sq ft.
Storage	69 sq ft.

Superior
Custom Homes
& Remodeling

William & Loree Beth Harris

Index of Drawings

DRAWING SCHEDULE	
Cover Page	1
Main Floor	2
2nd Floor	3
Foundation	4
Elevations 1	5
Elevation 2	6
Top Bird's Eye	7
Electrical Plans	8
Site plan	9


Superior
Custom Homes
& Remodeling

PHONE:

DRAWN BY: Randy Chambers


SCALE: As Noted

PAGE:
1 / 9

Cover Page

Notes:

All ceilings on this floor to be 10' unless otherwise noted

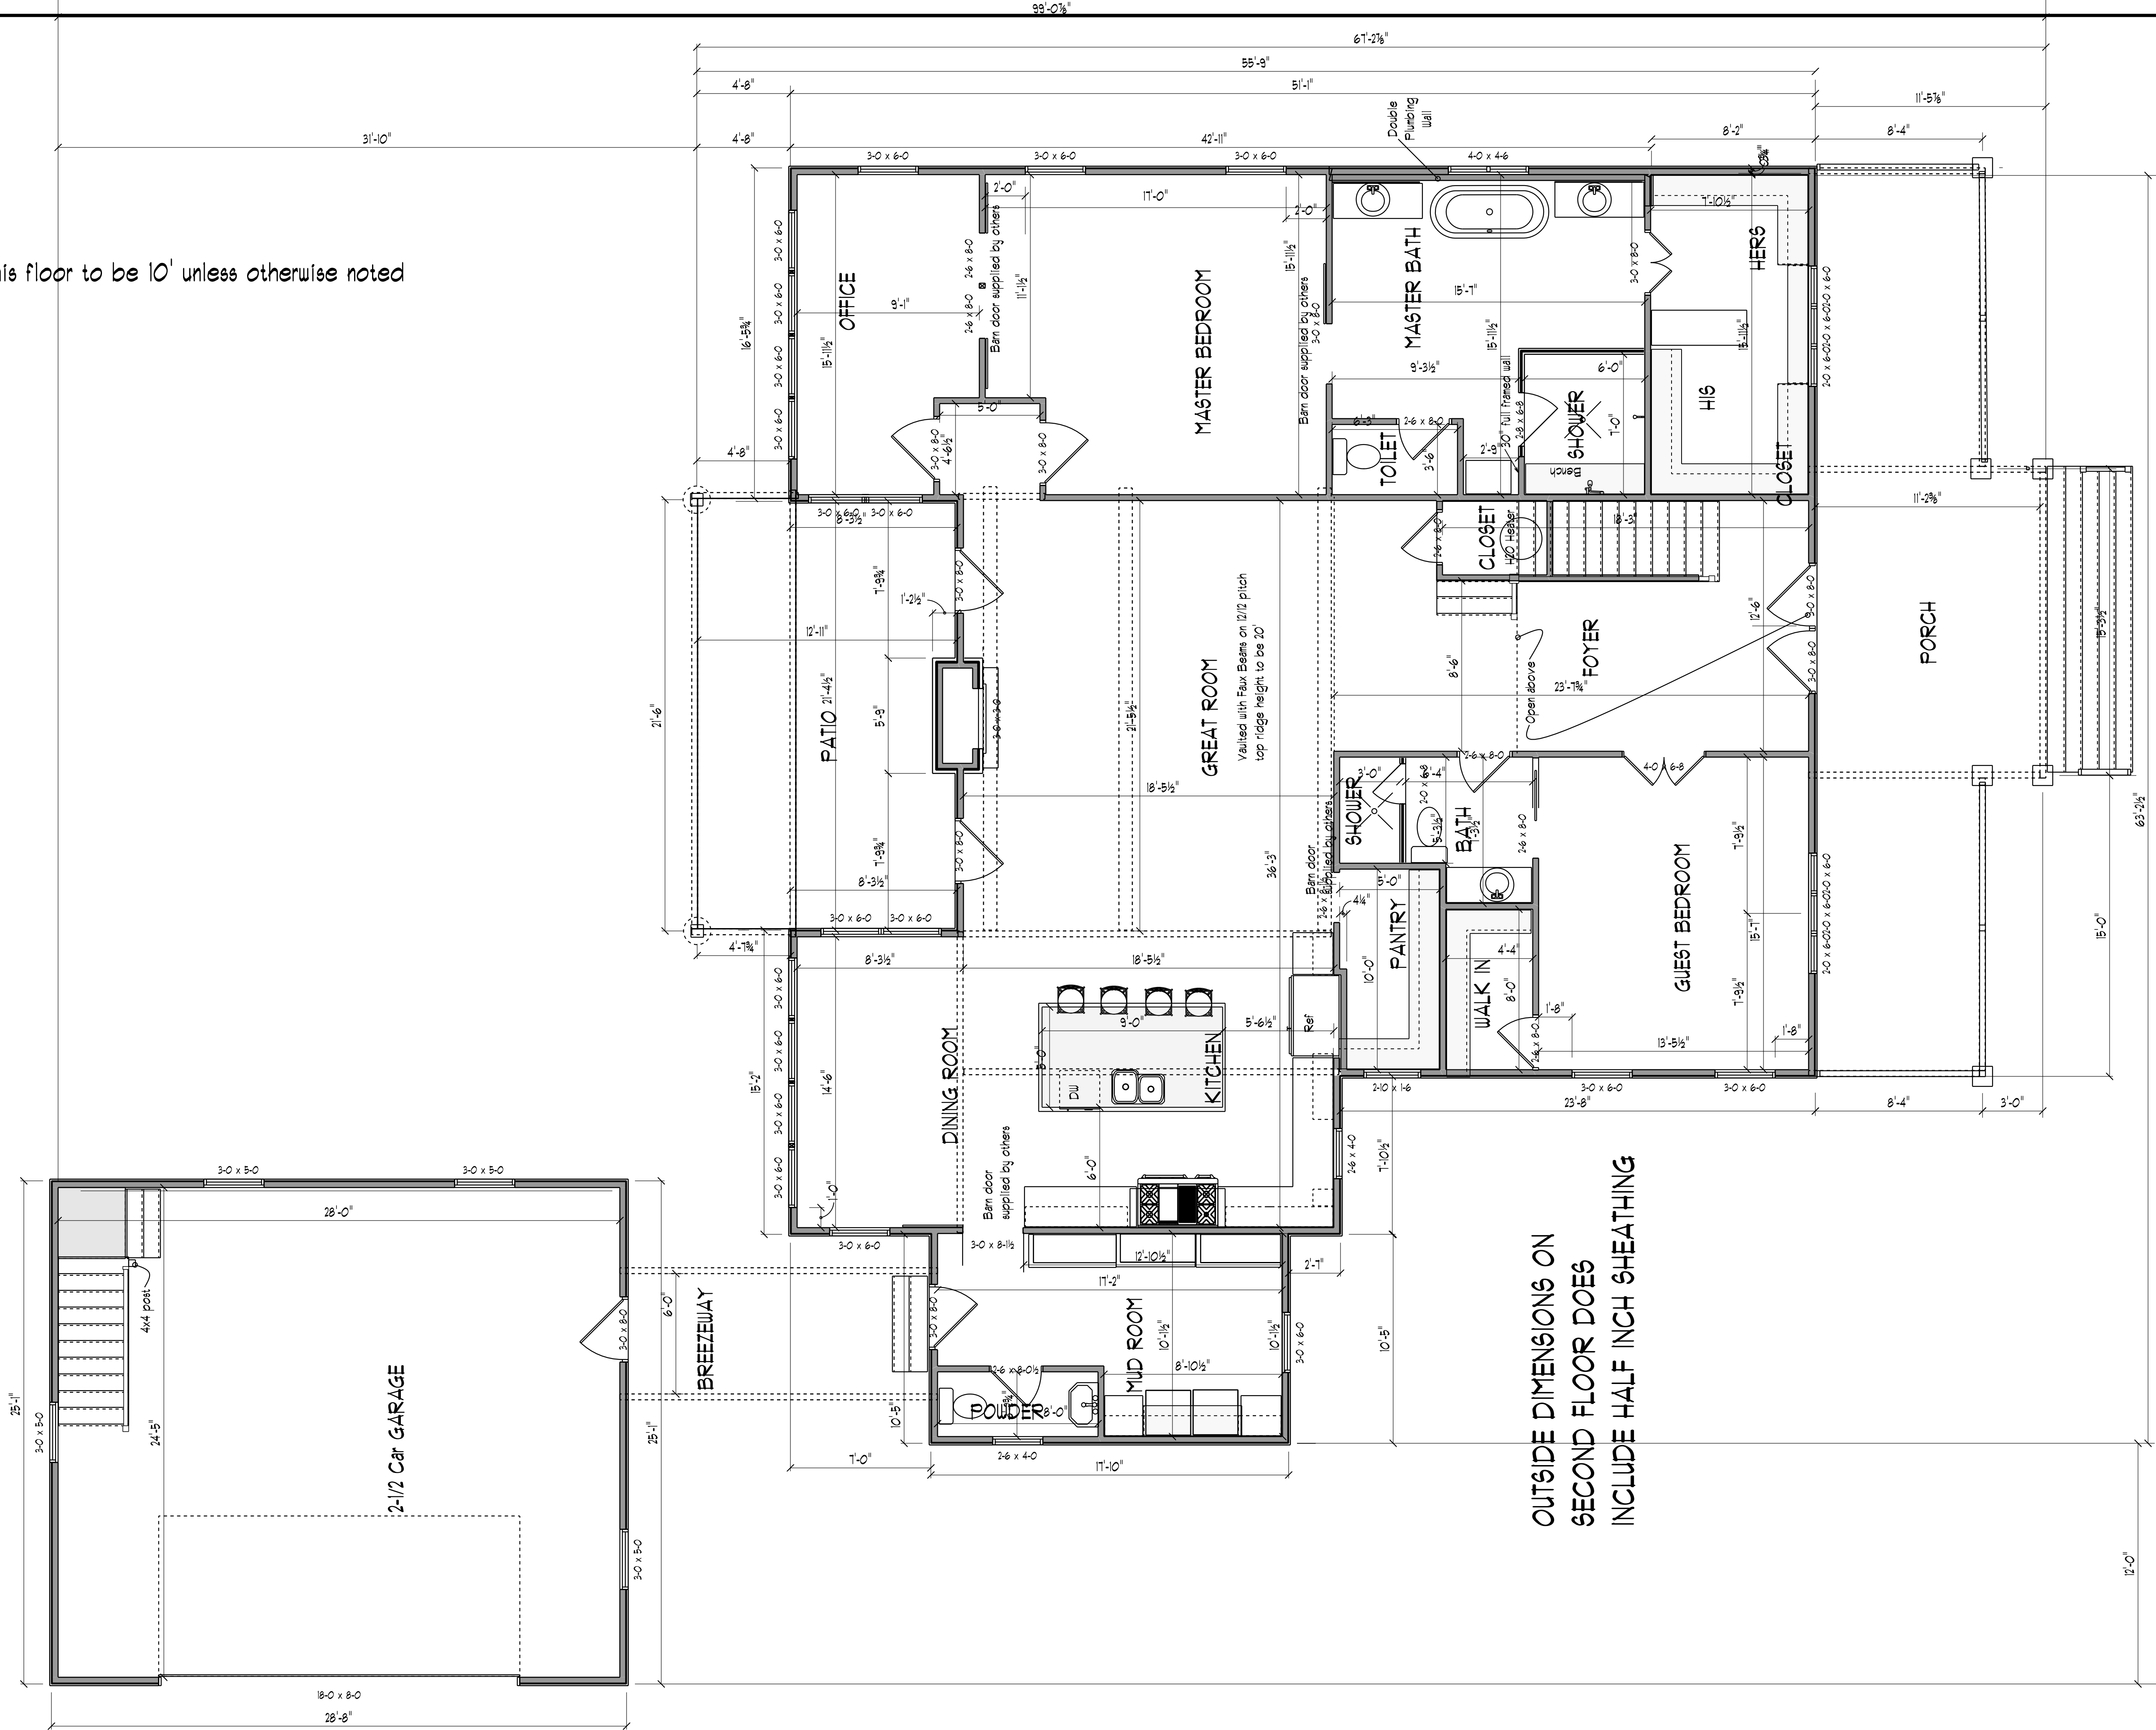

MAIN FLOOR FINAL
SCALE: 1/4" = 1'-0"

William & Loree Beth Harris

4309 Franklin Rd
Lebanon
Tennessee
37090



PHONE:

DRAWN BY: Matt Biceak

SCALE: 1/4" = 1'-0"

PAGE:

2 / 9

Main Floor

Revision		
REV	DATE	DESCRIPTION
A	10-17	Initial Release
B	11-28	For Quotation



Revision		
REV	DATE:	DESCRIPTION
A	11-28	Initial Release
William & Loree Beth Harris 4309 Franklin Rd Lebanon Tennessee 37090 PHONE:		
		
PHONE:		
DRAWN BY: Matt Blosak		
SCALE: 1/4" = 1'-0"		
PAGE: 4 / 9		
Foundation		



FINAL FRONT ELEVATION
SCALE: 1/4" = 1'-0"



FINAL REAR ELEVATION
SCALE: 1/4" = 1'-0"

Revision		
REV	DATE	DESCRIPTION
A	11-7	Initial Release
B	11-29	For Quotation

William & Loree Beth Harris

4309 Franklin Rd
Lebanon
Tennessee
37090

PHONE:

Superior
Custom Homes
& Remodeling

PHONE:

DRAWN BY: Matt Biceak

SCALE: 1/4" = 1'-0"

PAGE:

5 / 9

Elevations |



FINAL RIGHT ELEVATION
SCALE: 1/4" = 1'-0"



FINAL LEFT ELEVATION
SCALE: 1/4" = 1'-0"

Revision		
REV	DATE	DESCRIPTION
A	11-7	Initial Release
B	11-29	For Quotation

William & Loree Beth Harris

4309 Franklin Rd
Lebanon
Tennessee
37090

PHONE:

Superior
Custom Homes
& Remodeling

PHONE:


DRAWN BY: Matt Biceak

SCALE: 1/4" = 1'-0"

PAGE:

6 / 9

Elevation 2

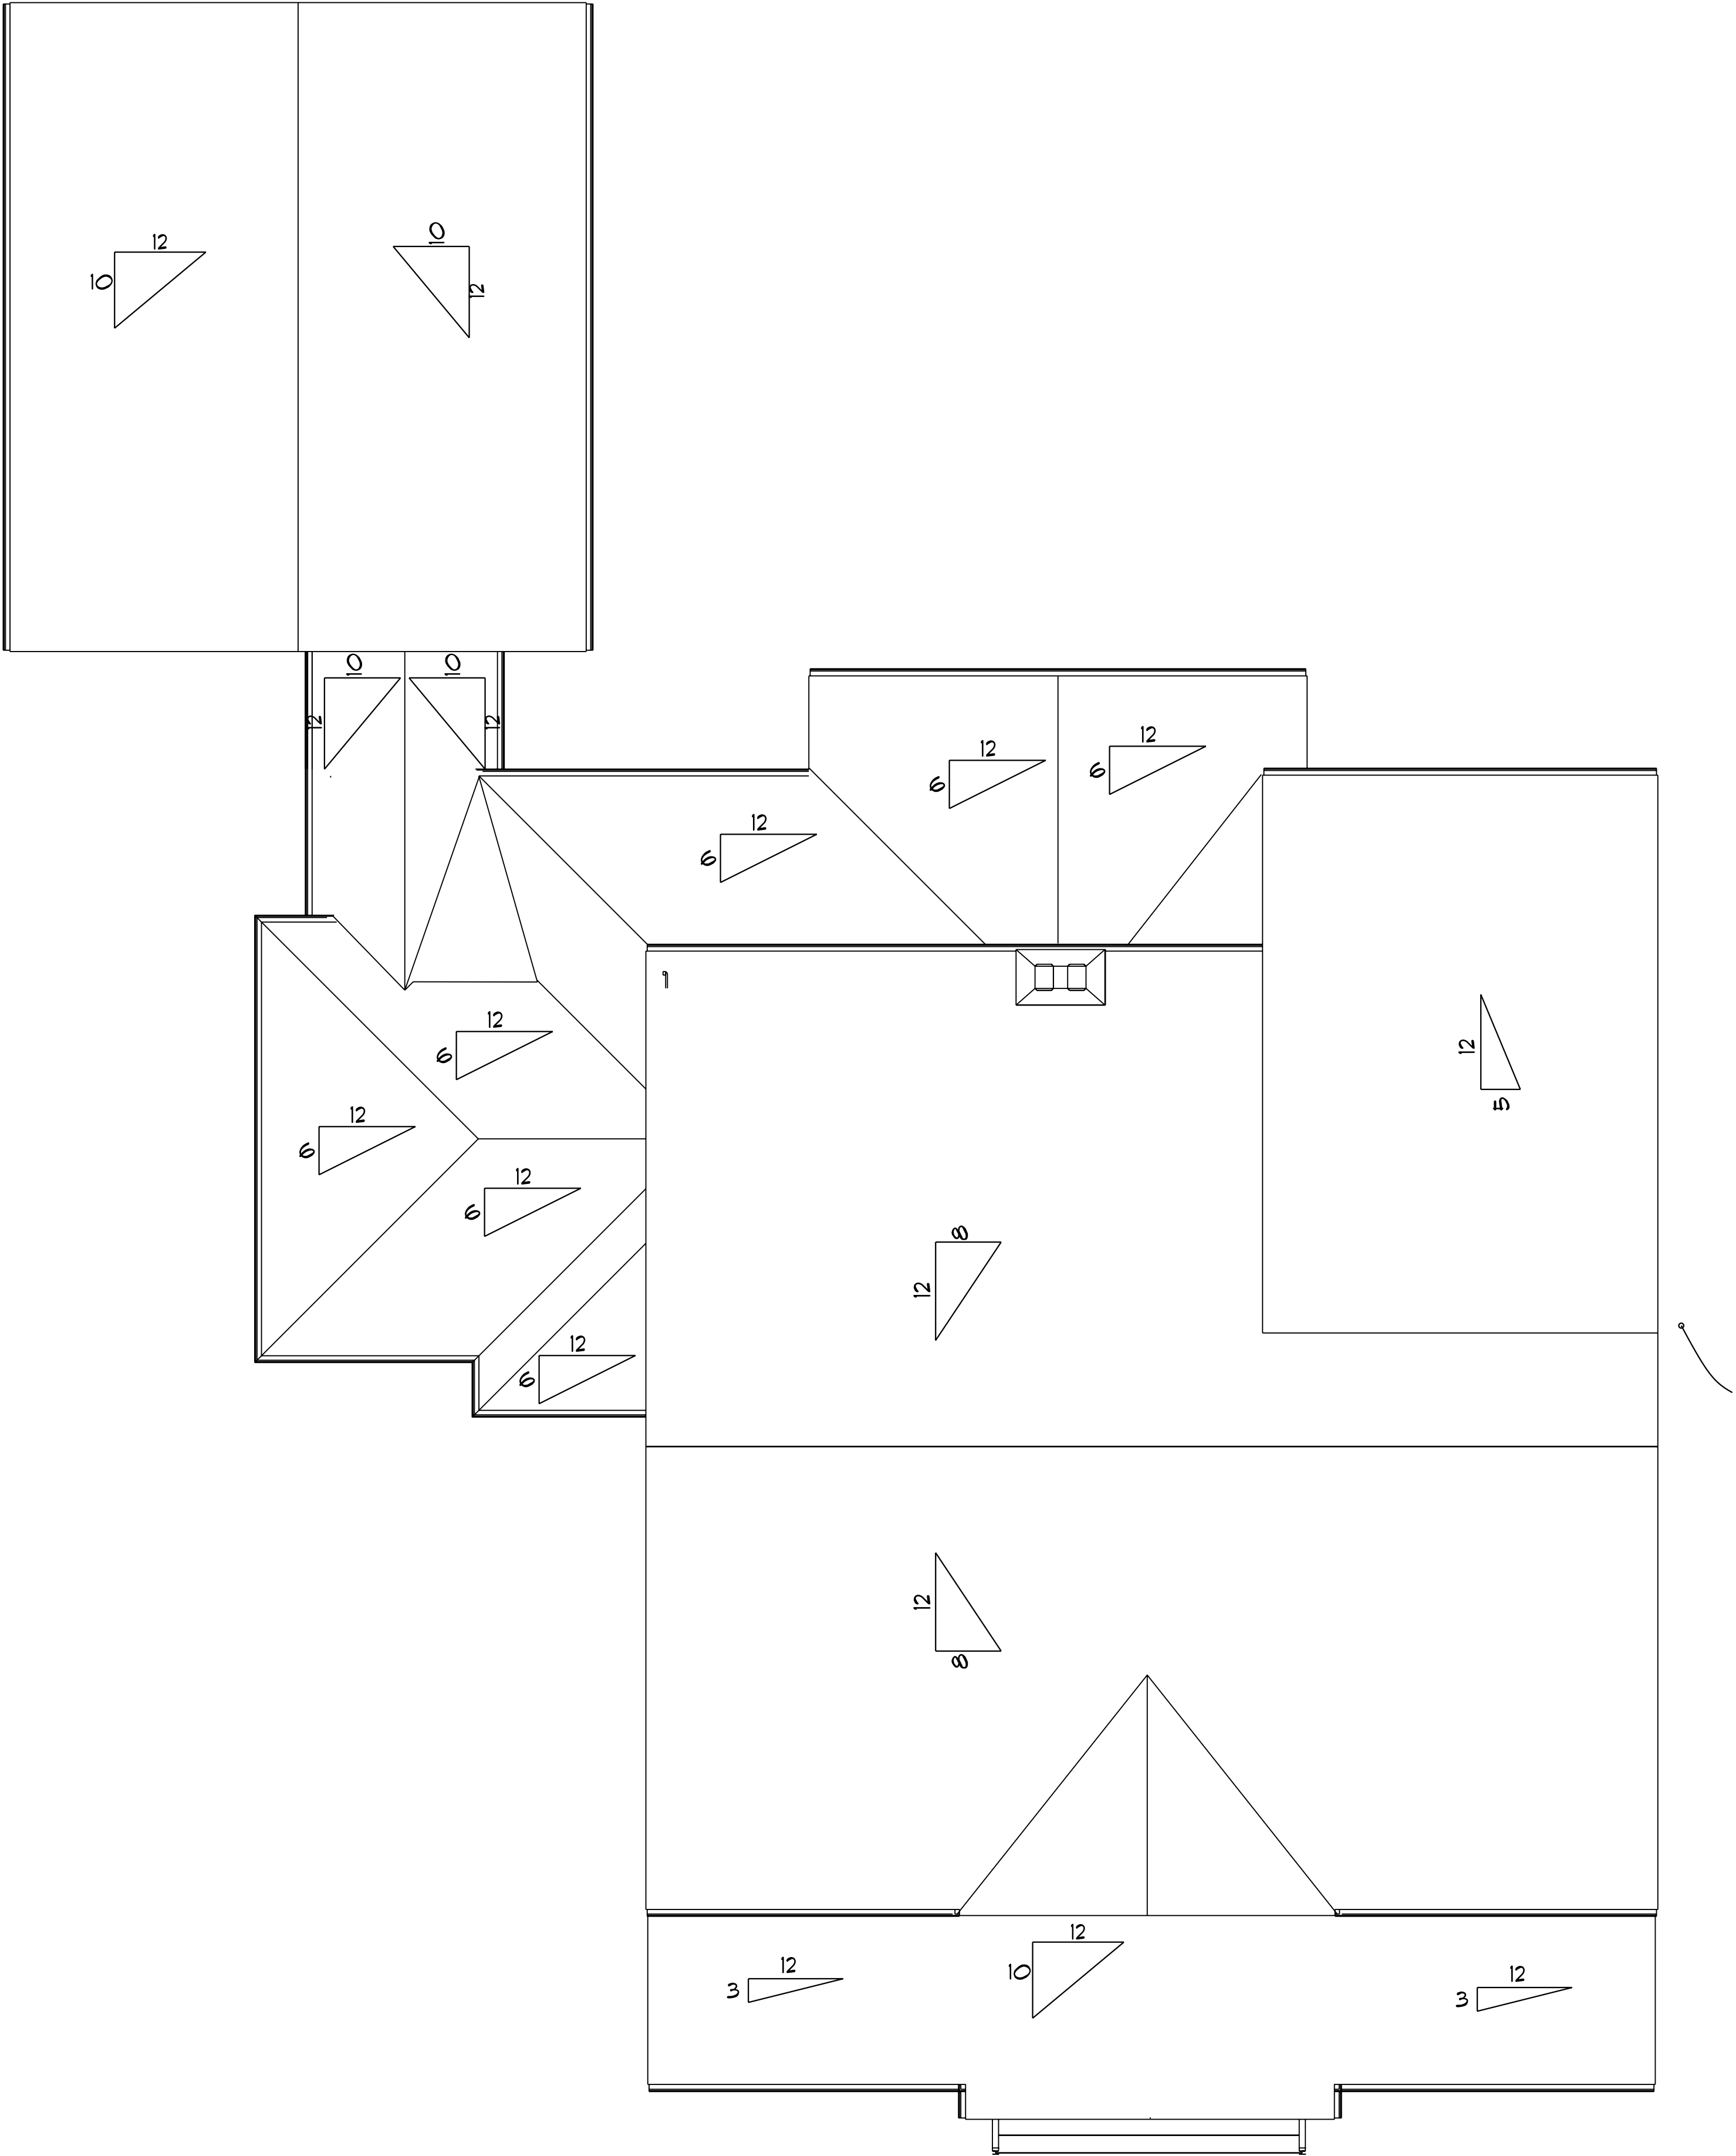

Birds Eye
SCALE: 3/16" = 1'-0"

Revision		
REV	DATE	DESCRIPTION
A	10-17	Initial Release
B	11-29	For Quotation

William & Loree Beth Harris

4309 Franklin Rd
Lebanon
Tennessee
37090

PHONE:




PHONE:

DRAWN BY: Matt Blossek



SCALE: 3/16" = 1'-0"

PAGE:
7 / 9

Top Bird's Eye

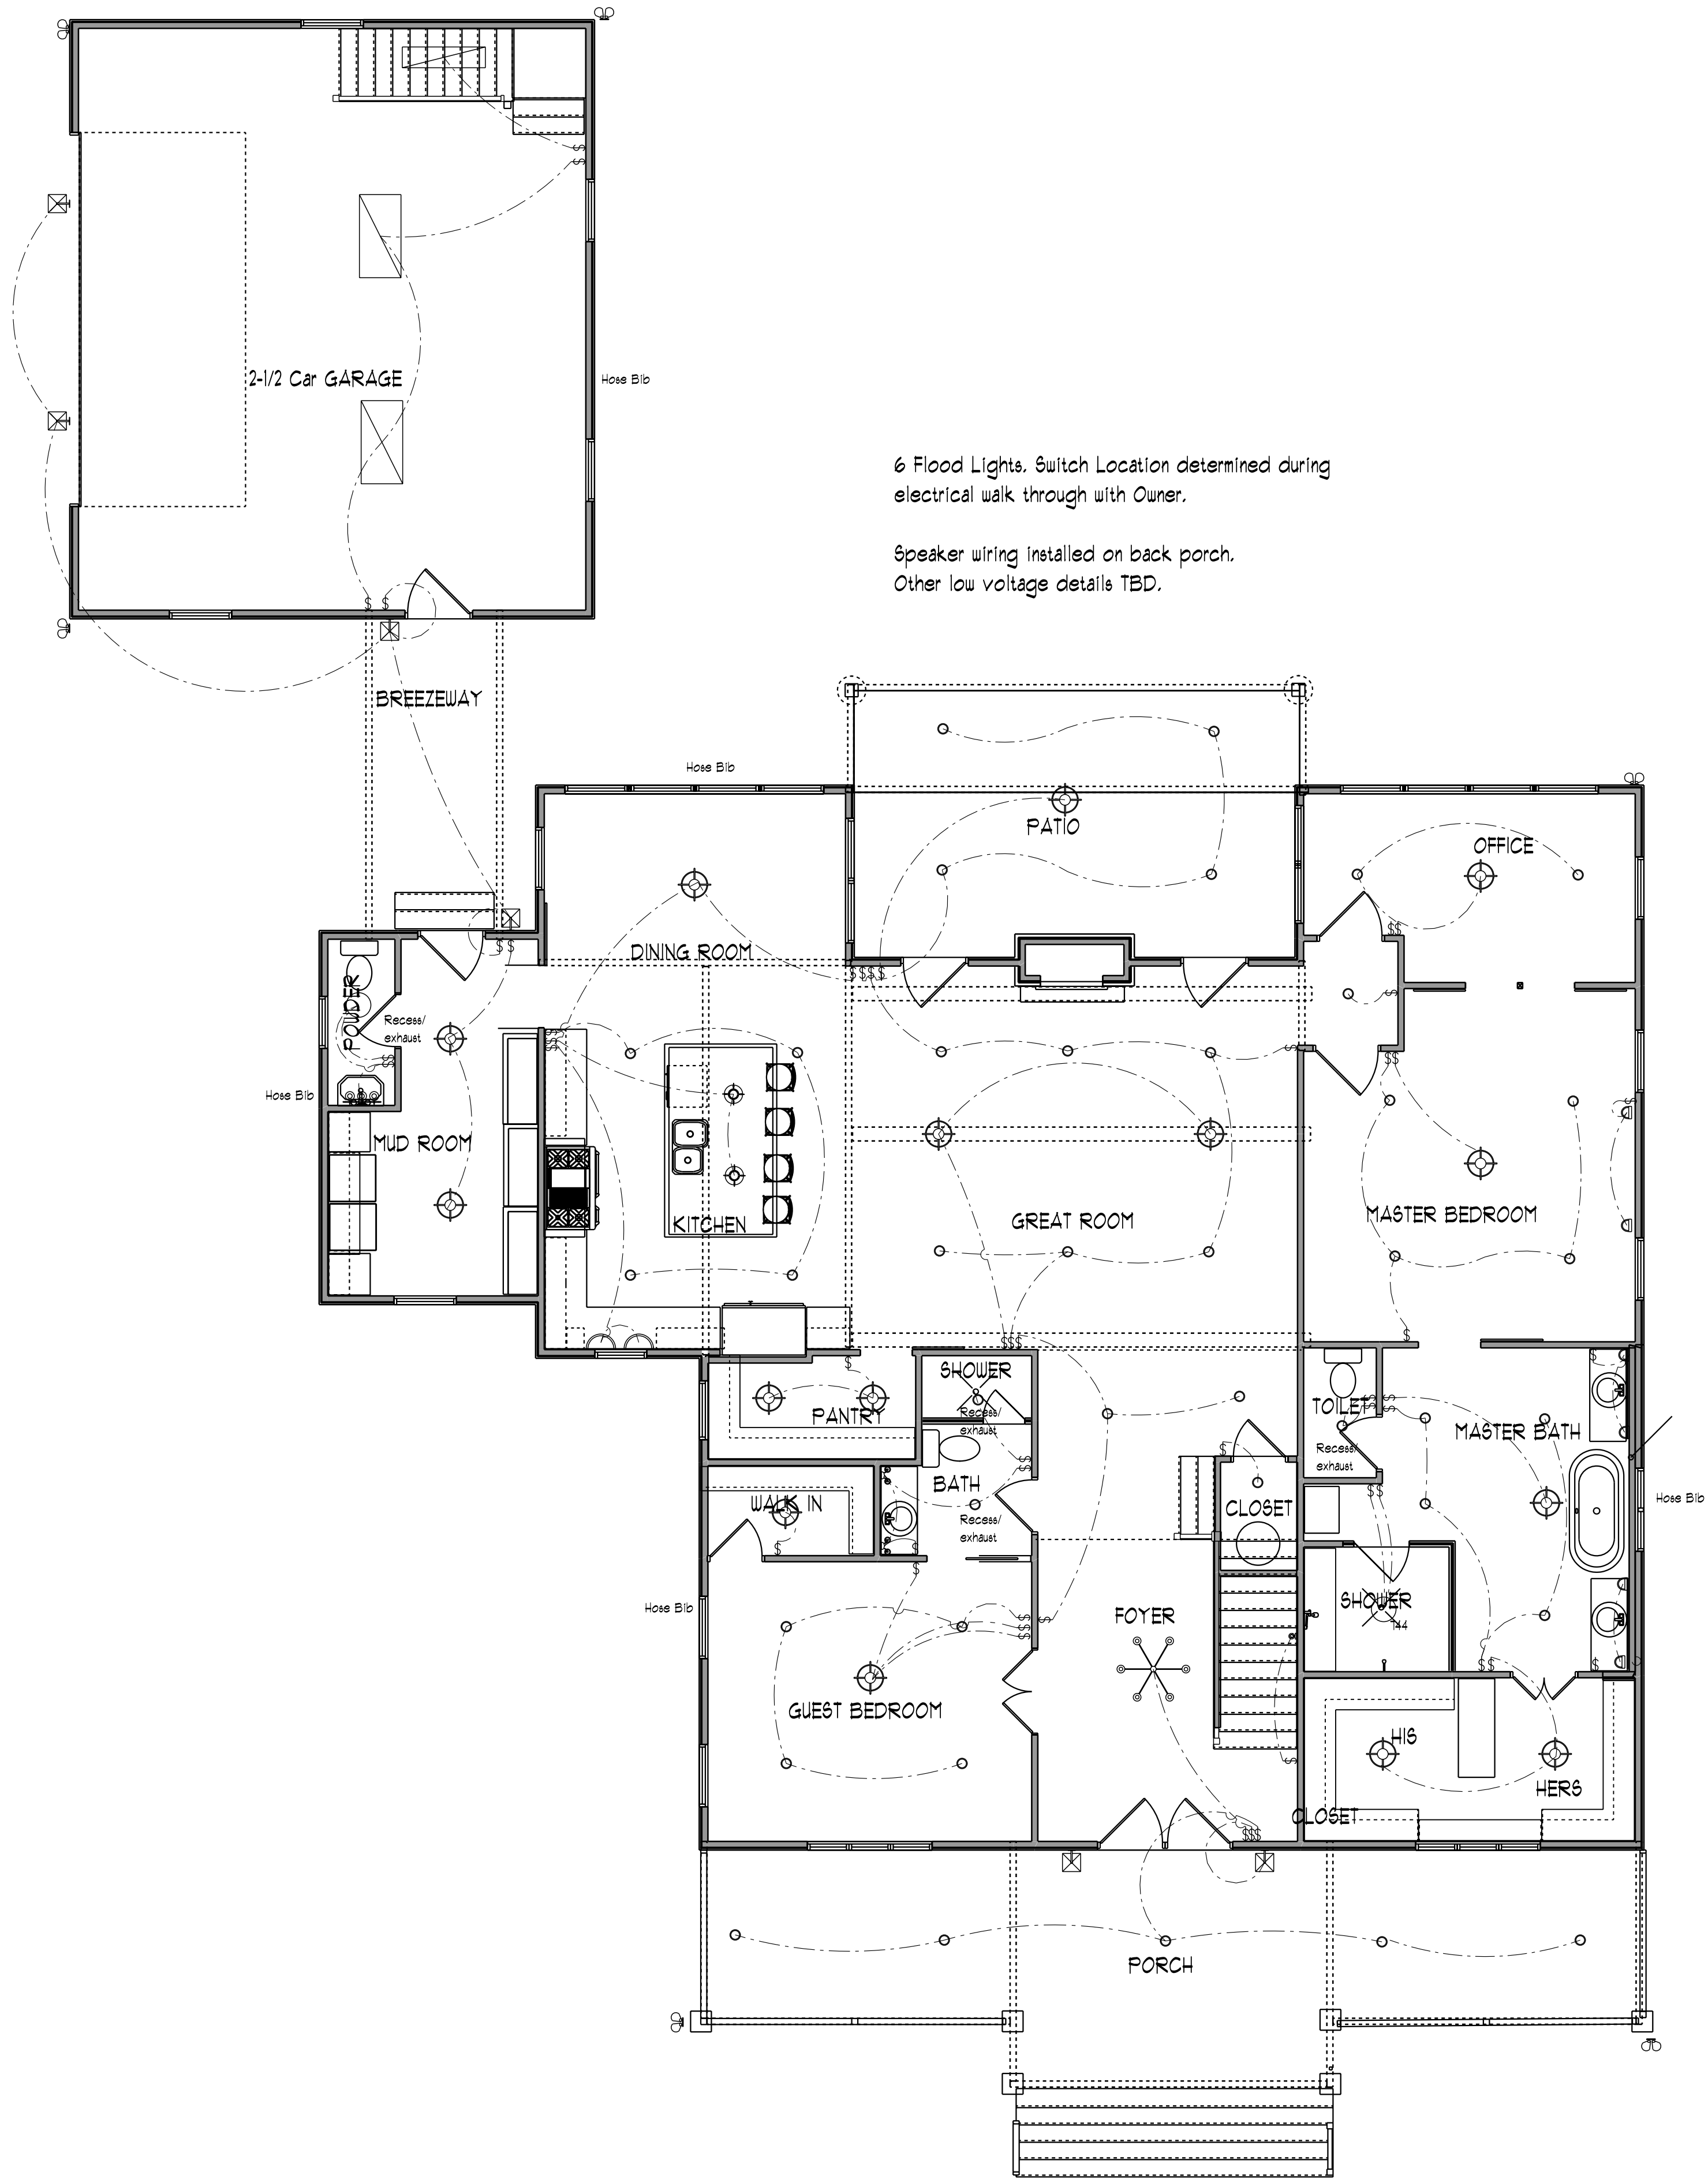

 MAIN FLOOR FINAL - ELECTRICAL
SCALE: 3/16" = 1'-0"

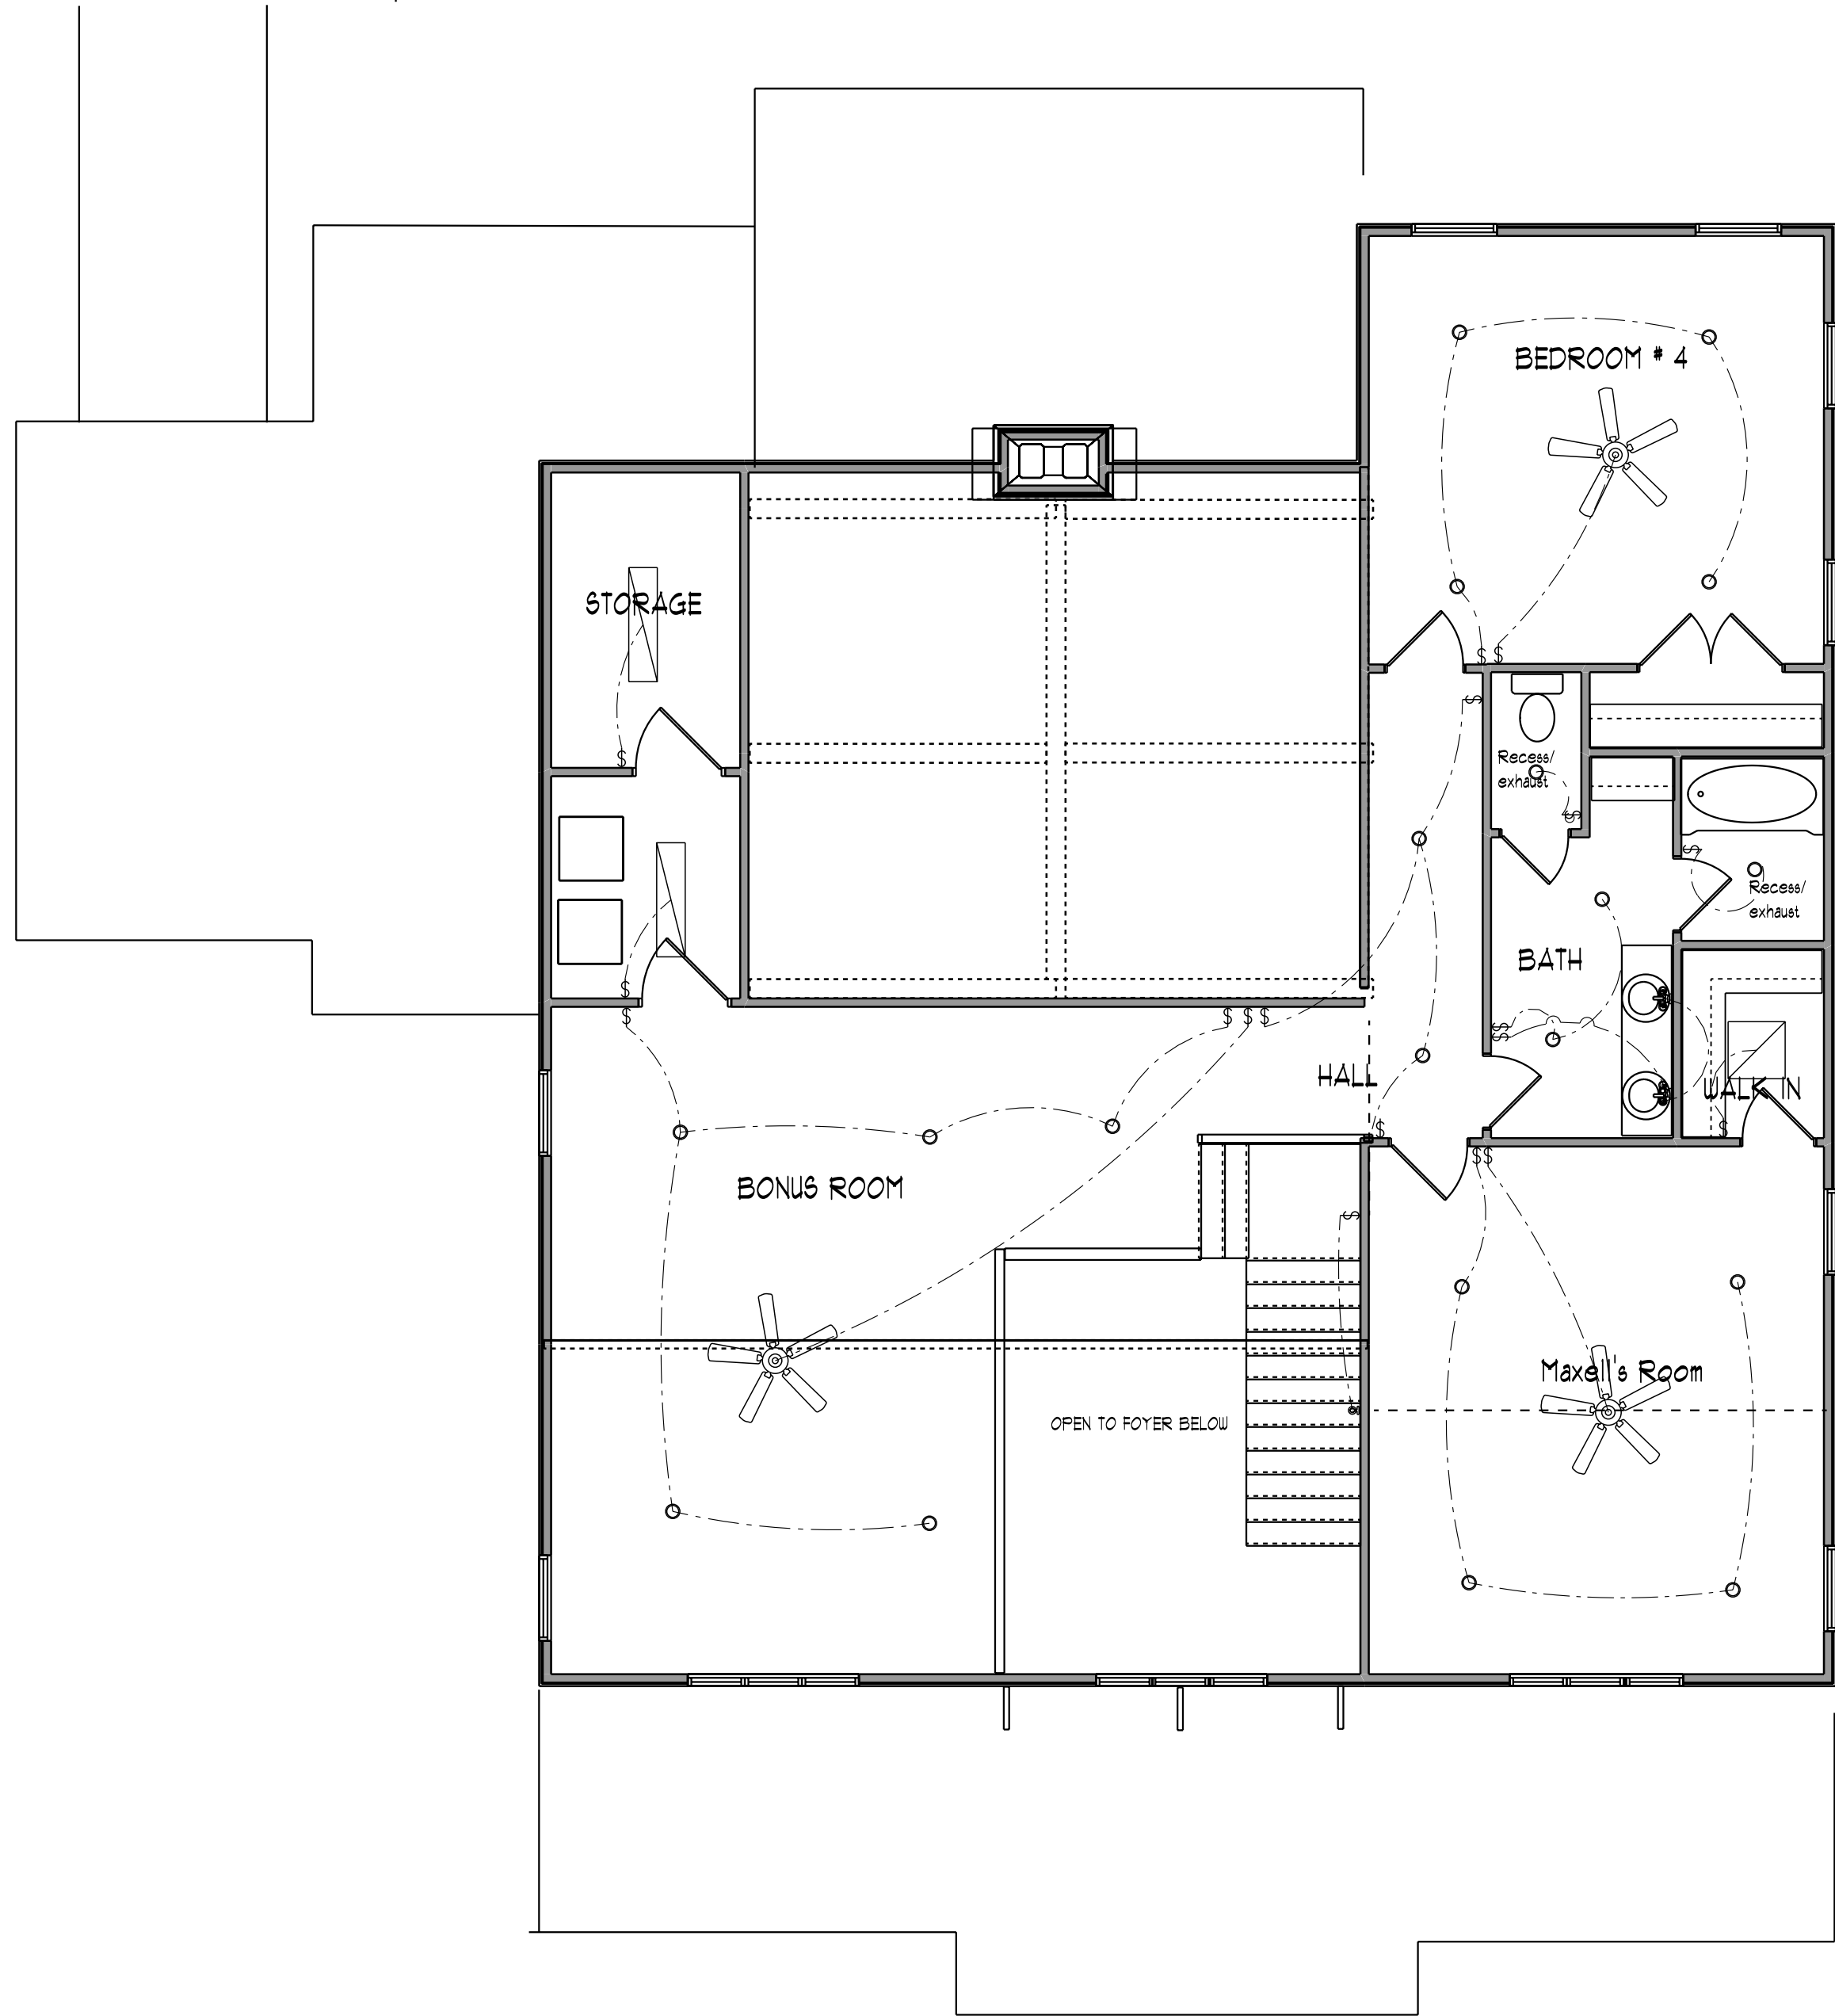

SECOND FLOOR FINAL - ELECTRICAL
SCALE: 3/16" = 1'-0"

William & Loree Beth Harris

4309 Franklin Rd
Lebanon
Tennessee 37090

PHONE:

Superior
Custom Homes
& Remodeling

PHONE:

DRAWN BY: Matt Blossek

SCALE: 3/16" = 1'-0"

PAGE:

8 / 9

Electrical Plans

